


Project Name: **PLUMBING SKETCH EXAMPLES**

Sheet No. **1** of \_\_\_\_\_

Calculated By: \_\_\_\_\_ Date: \_\_\_\_\_ Checked By: \_\_\_\_\_ Date: \_\_\_\_\_

(DESIGN ASSUMPTIONS, IF ANY, LISTED BELOW)

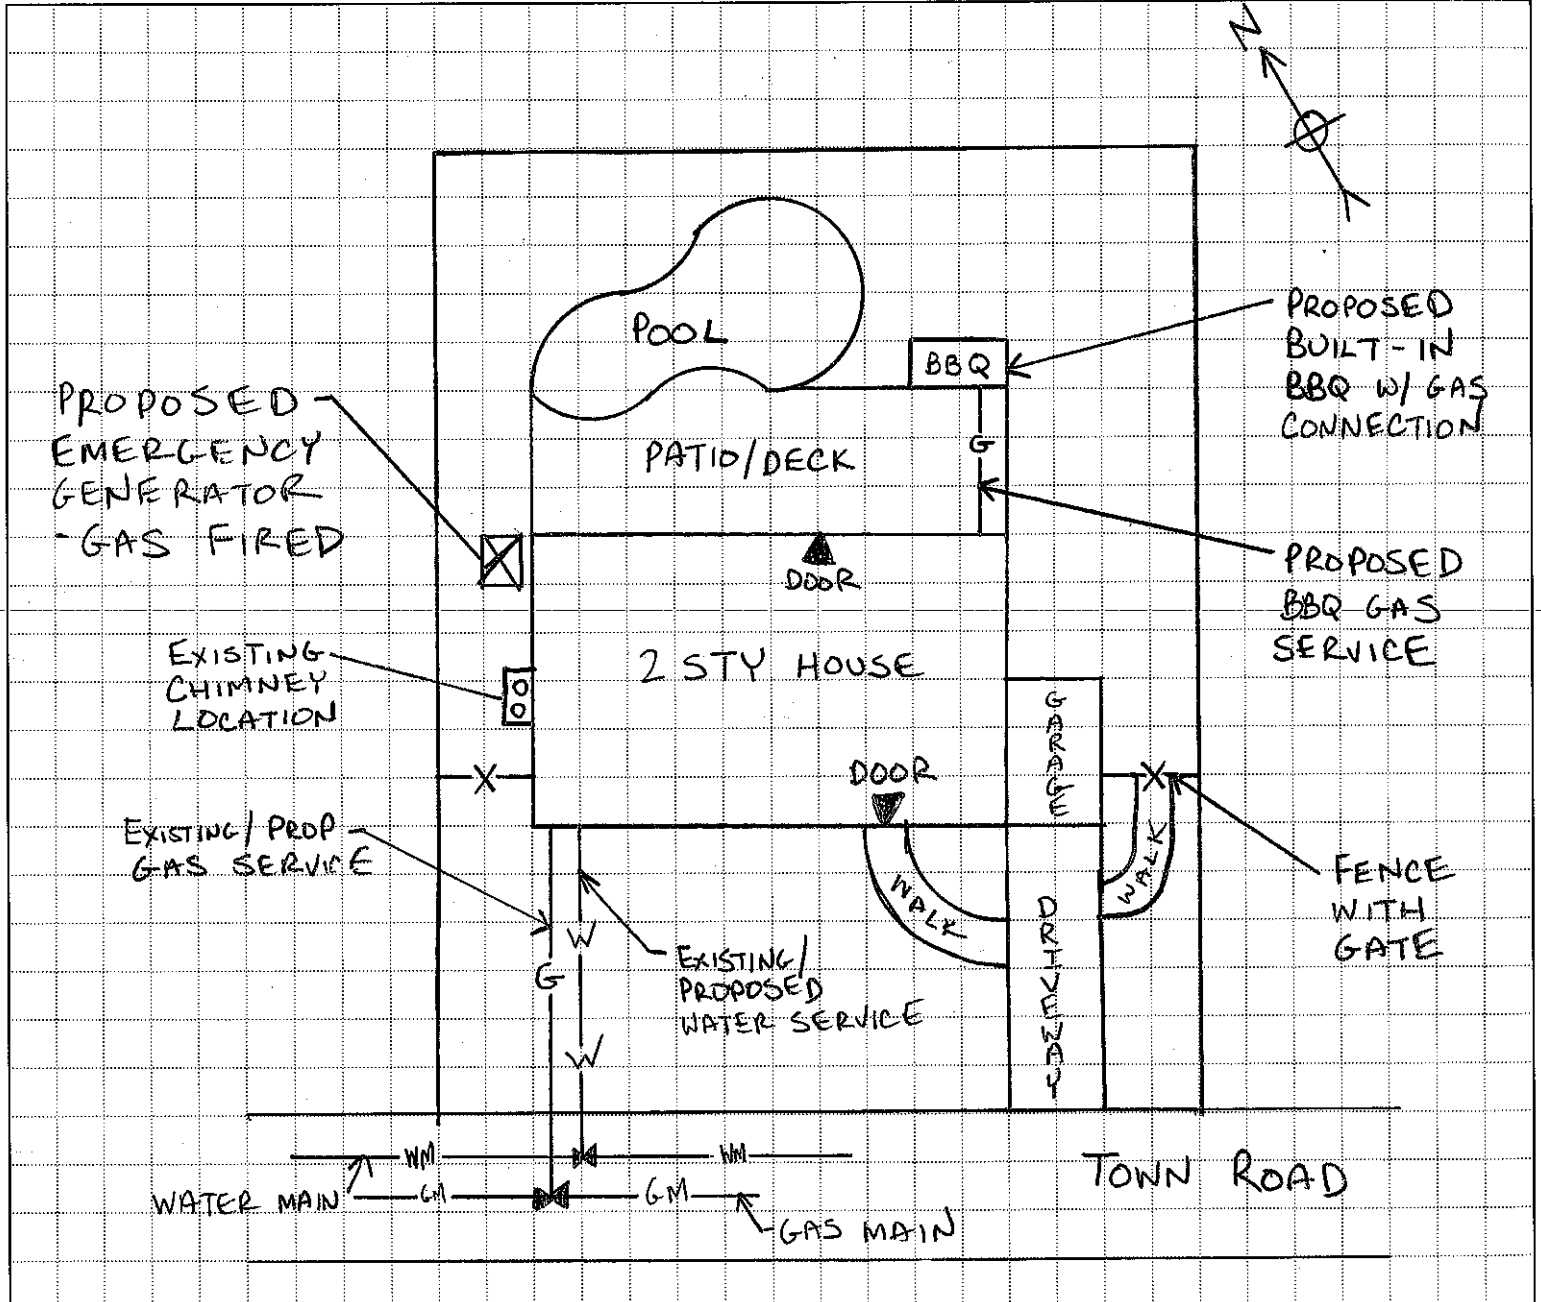

SCALE AS NOTED

**NOTE**

UP TO DATE PROPERTY  
SURVEYS MAY BE  
USED AS SITE PLANS.  
MARK ALL PROPOSED WORK  
ON SURVEY W/ RED/BLUE INK.

OWNER NAME  
OWNER ADDRESS  
PLUMBER NAME & LIC.#


**SITE PLAN**

Project Name: PLUMBING SKETCH EXAMPLES


Sheet No. 2 of     

Calculated By: \_\_\_\_\_ Date: \_\_\_\_\_ Checked By: \_\_\_\_\_ Date: \_\_\_\_\_

(DESIGN ASSUMPTIONS, IF ANY, LISTED BELOW)

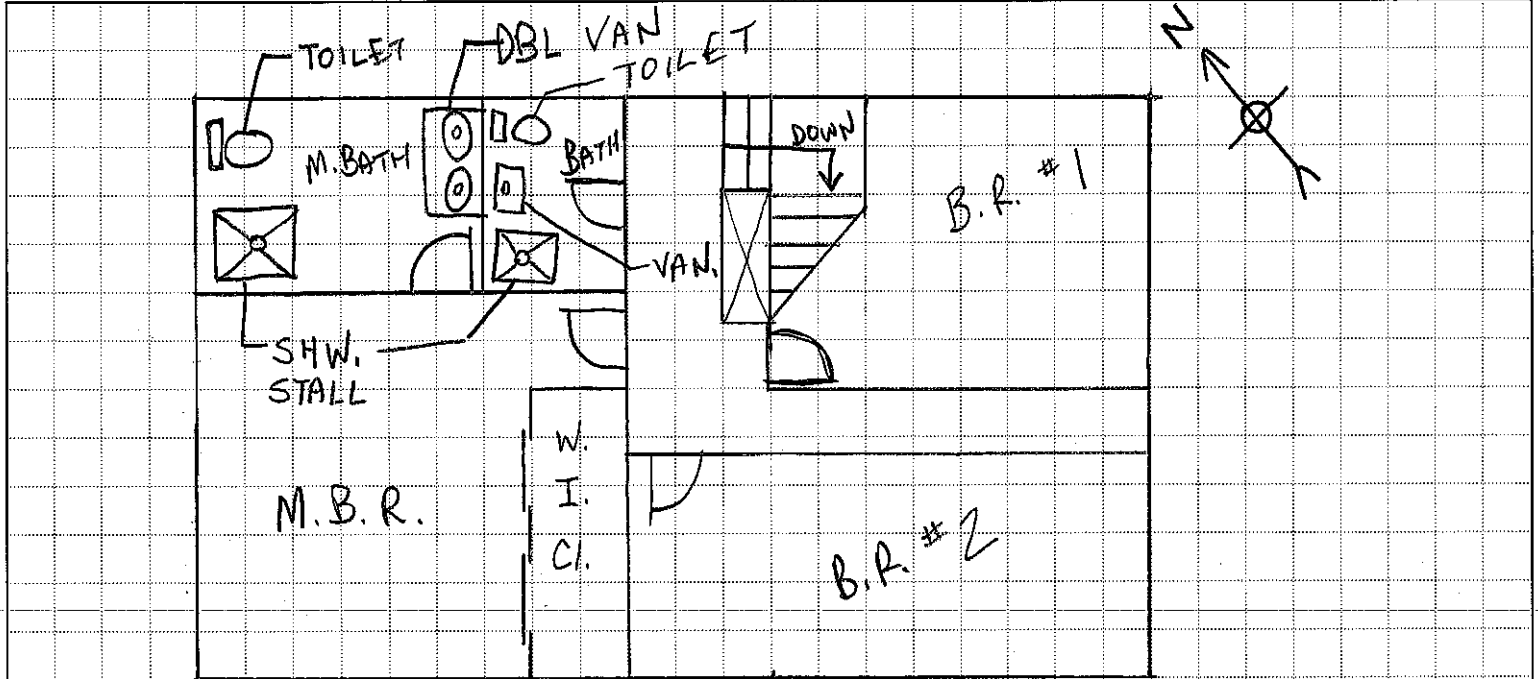

SECOND FLOOR PLAN  
SCALE AS NOTED

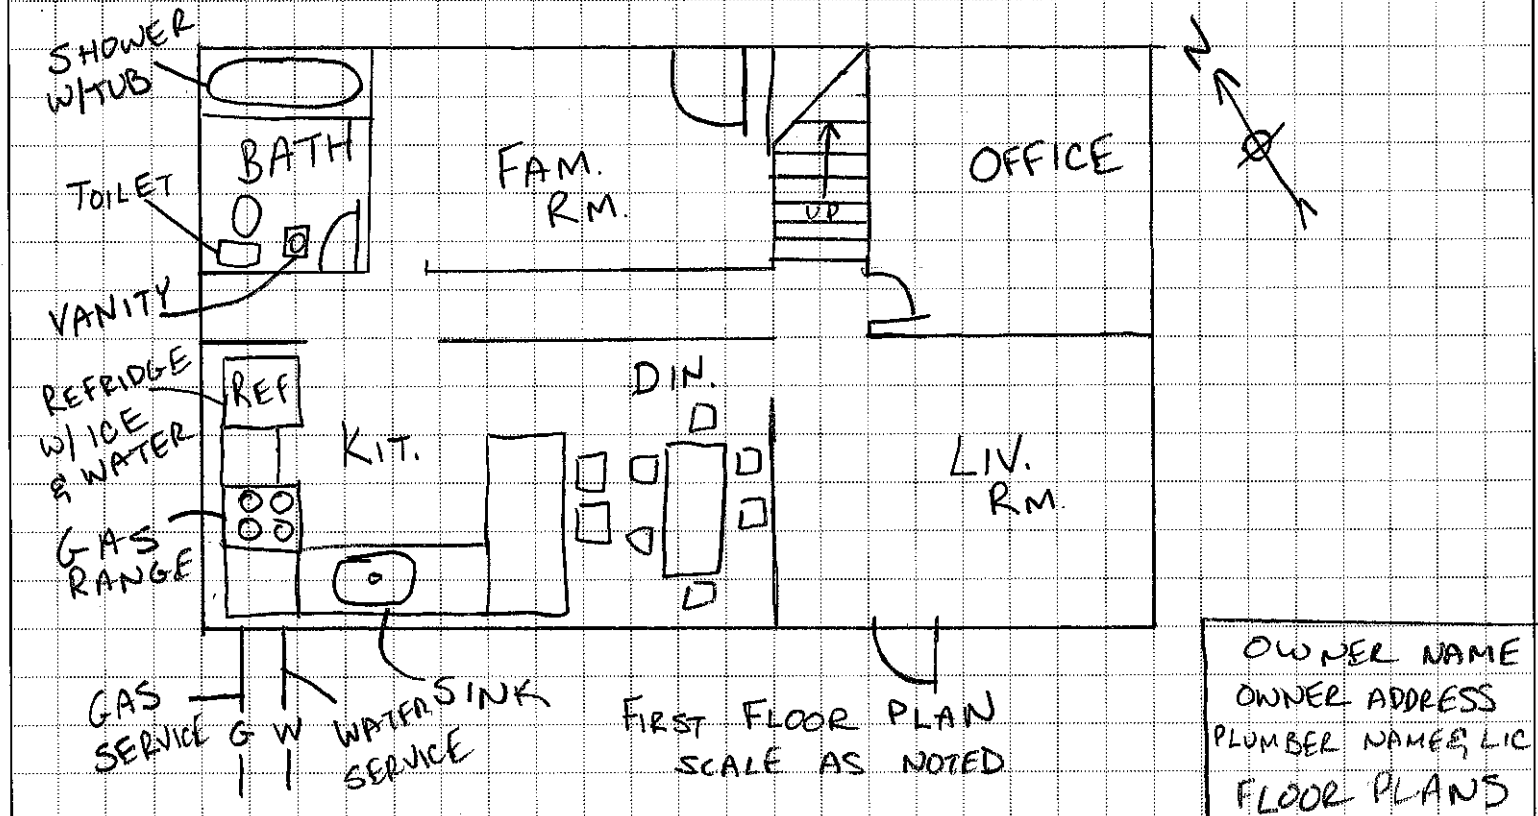

FIRST FLOOR PLAN  
SCALE AS NOTED


OWNER NAME  
OWNER ADDRESS  
PLUMBER NAME, LIC  
FLOOR PLANS

Project Name: PLUMBING SKETCH EXAMPLES

Sheet No. 3 of \_\_\_\_\_

Calculated By: \_\_\_\_\_ Date: \_\_\_\_\_ Checked By: \_\_\_\_\_ Date: \_\_\_\_\_

(DESIGN ASSUMPTIONS, IF ANY, LISTED BELOW)

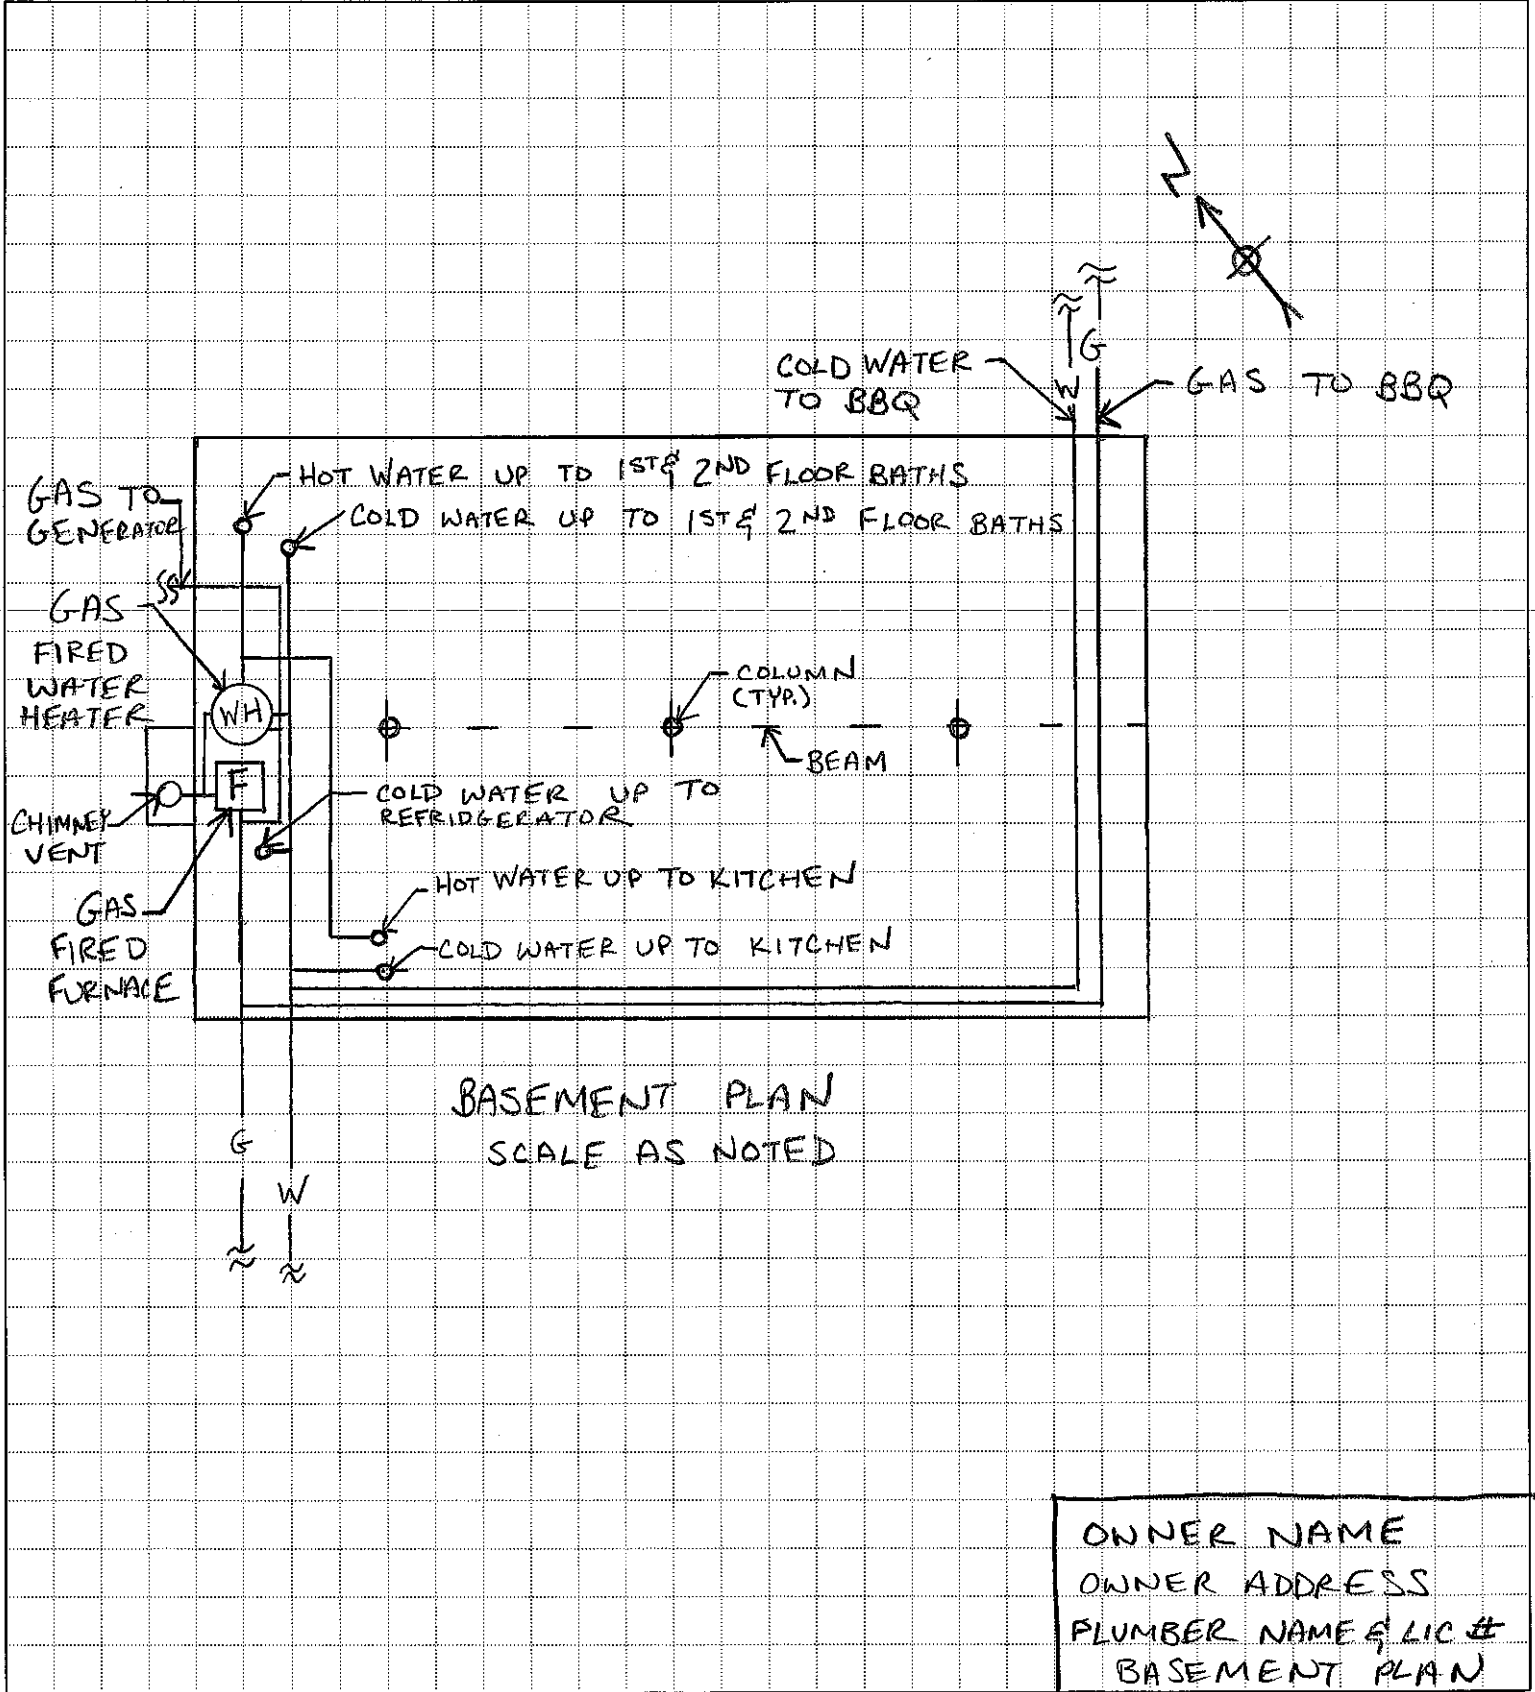


OWNER NAME  
OWNER ADDRESS  
PLUMBER NAME & LIC #  
BASEMENT PLAN

Project Name: PLUMBING SKETCH EXAMPLES

Sheet No. 4 of         


Calculated By:    Date:                  Checked By:    Date:                 

(DESIGN ASSUMPTIONS, IF ANY, LISTED BELOW)

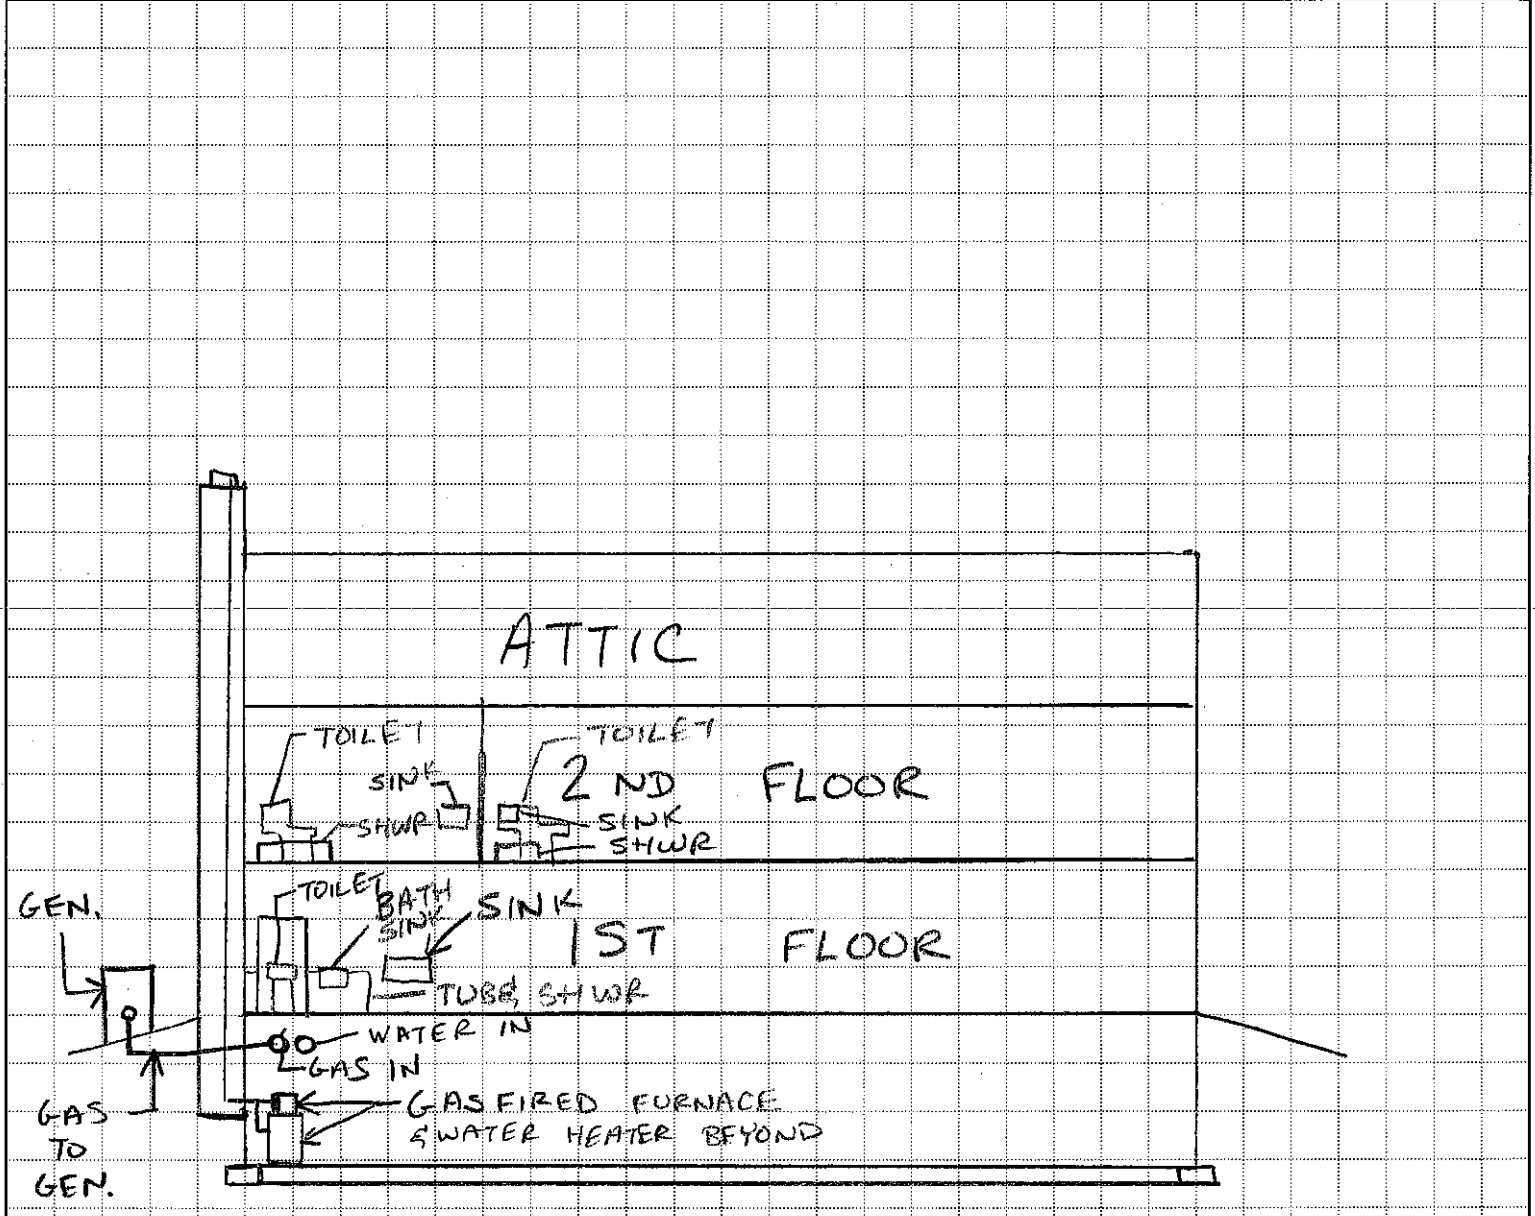

SECTION  
SCALE AS NOTED

OWNER NAME  
OWNER ADDRESS  
PLUMBER NAME, LIC#  
SECTION

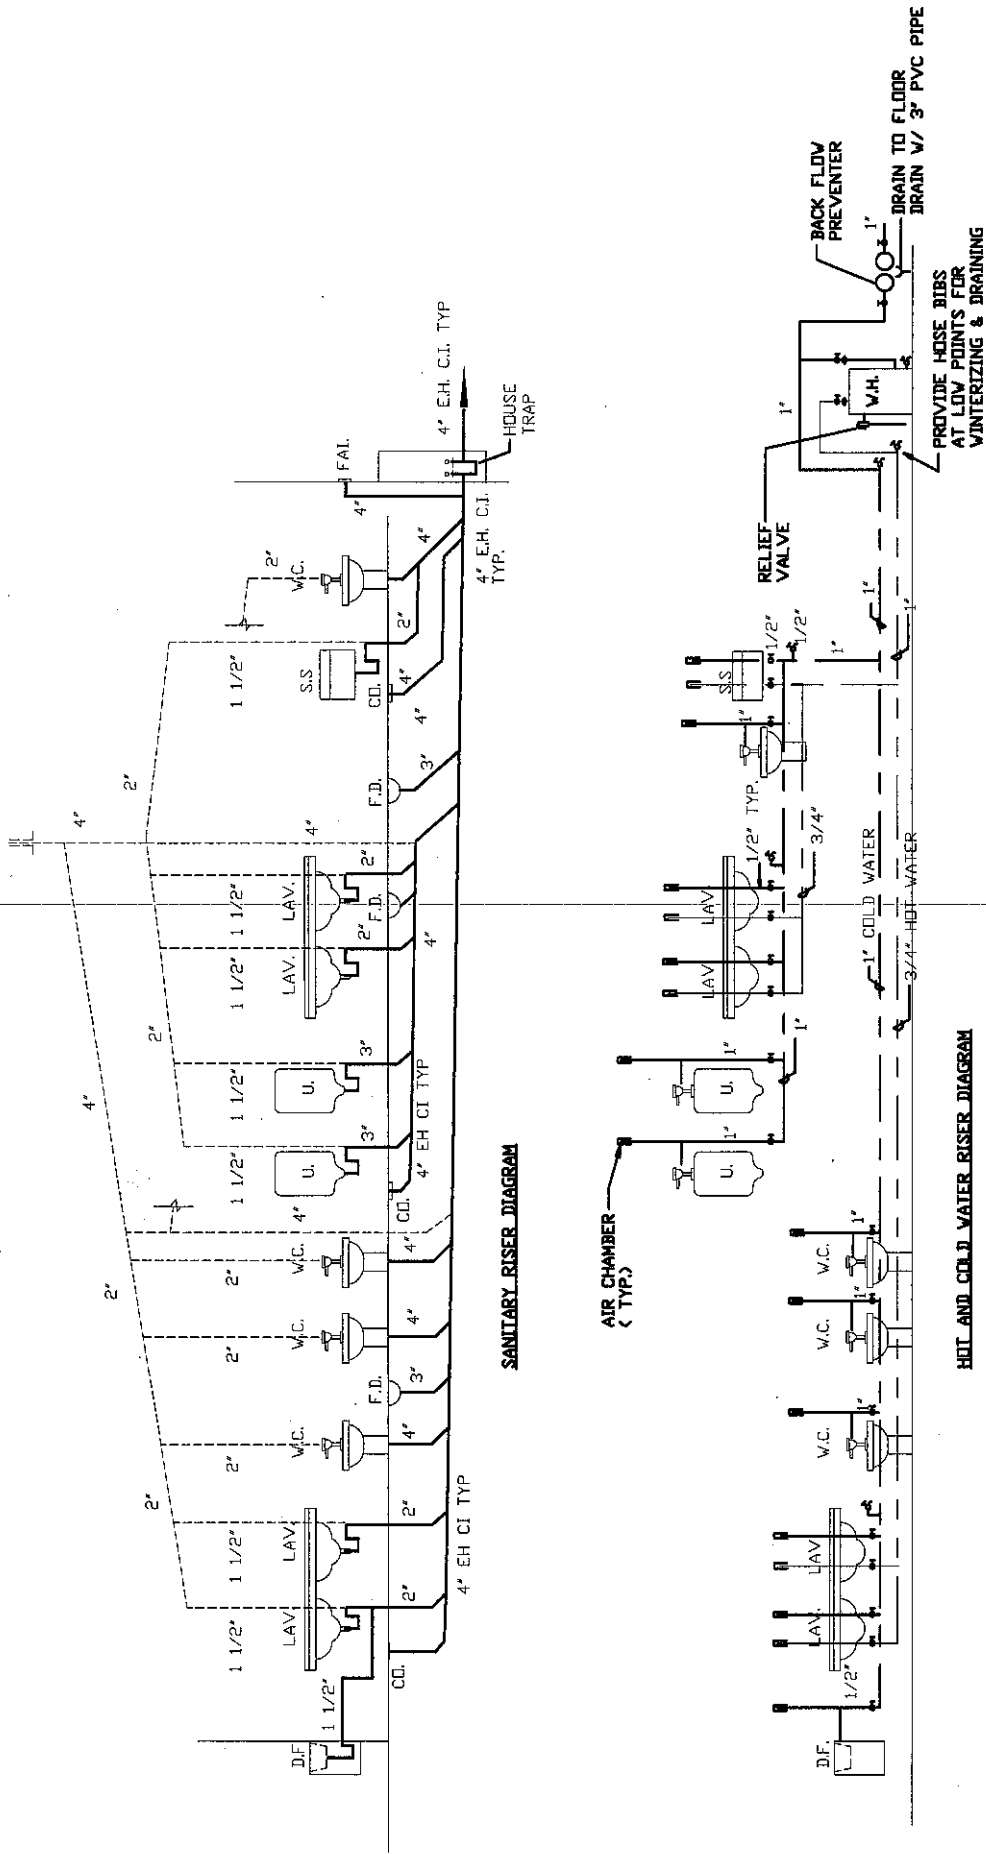

PLUMBING RISER DIAGRAMS

2  
A-3

N.T.S.